


BUILDING METHOD OF
 LAYOUT LOCATE GRID A-2

ACCESS DRIVE

BUILDING METHOD OF
 LAYOUT LOCATE GRID F-2

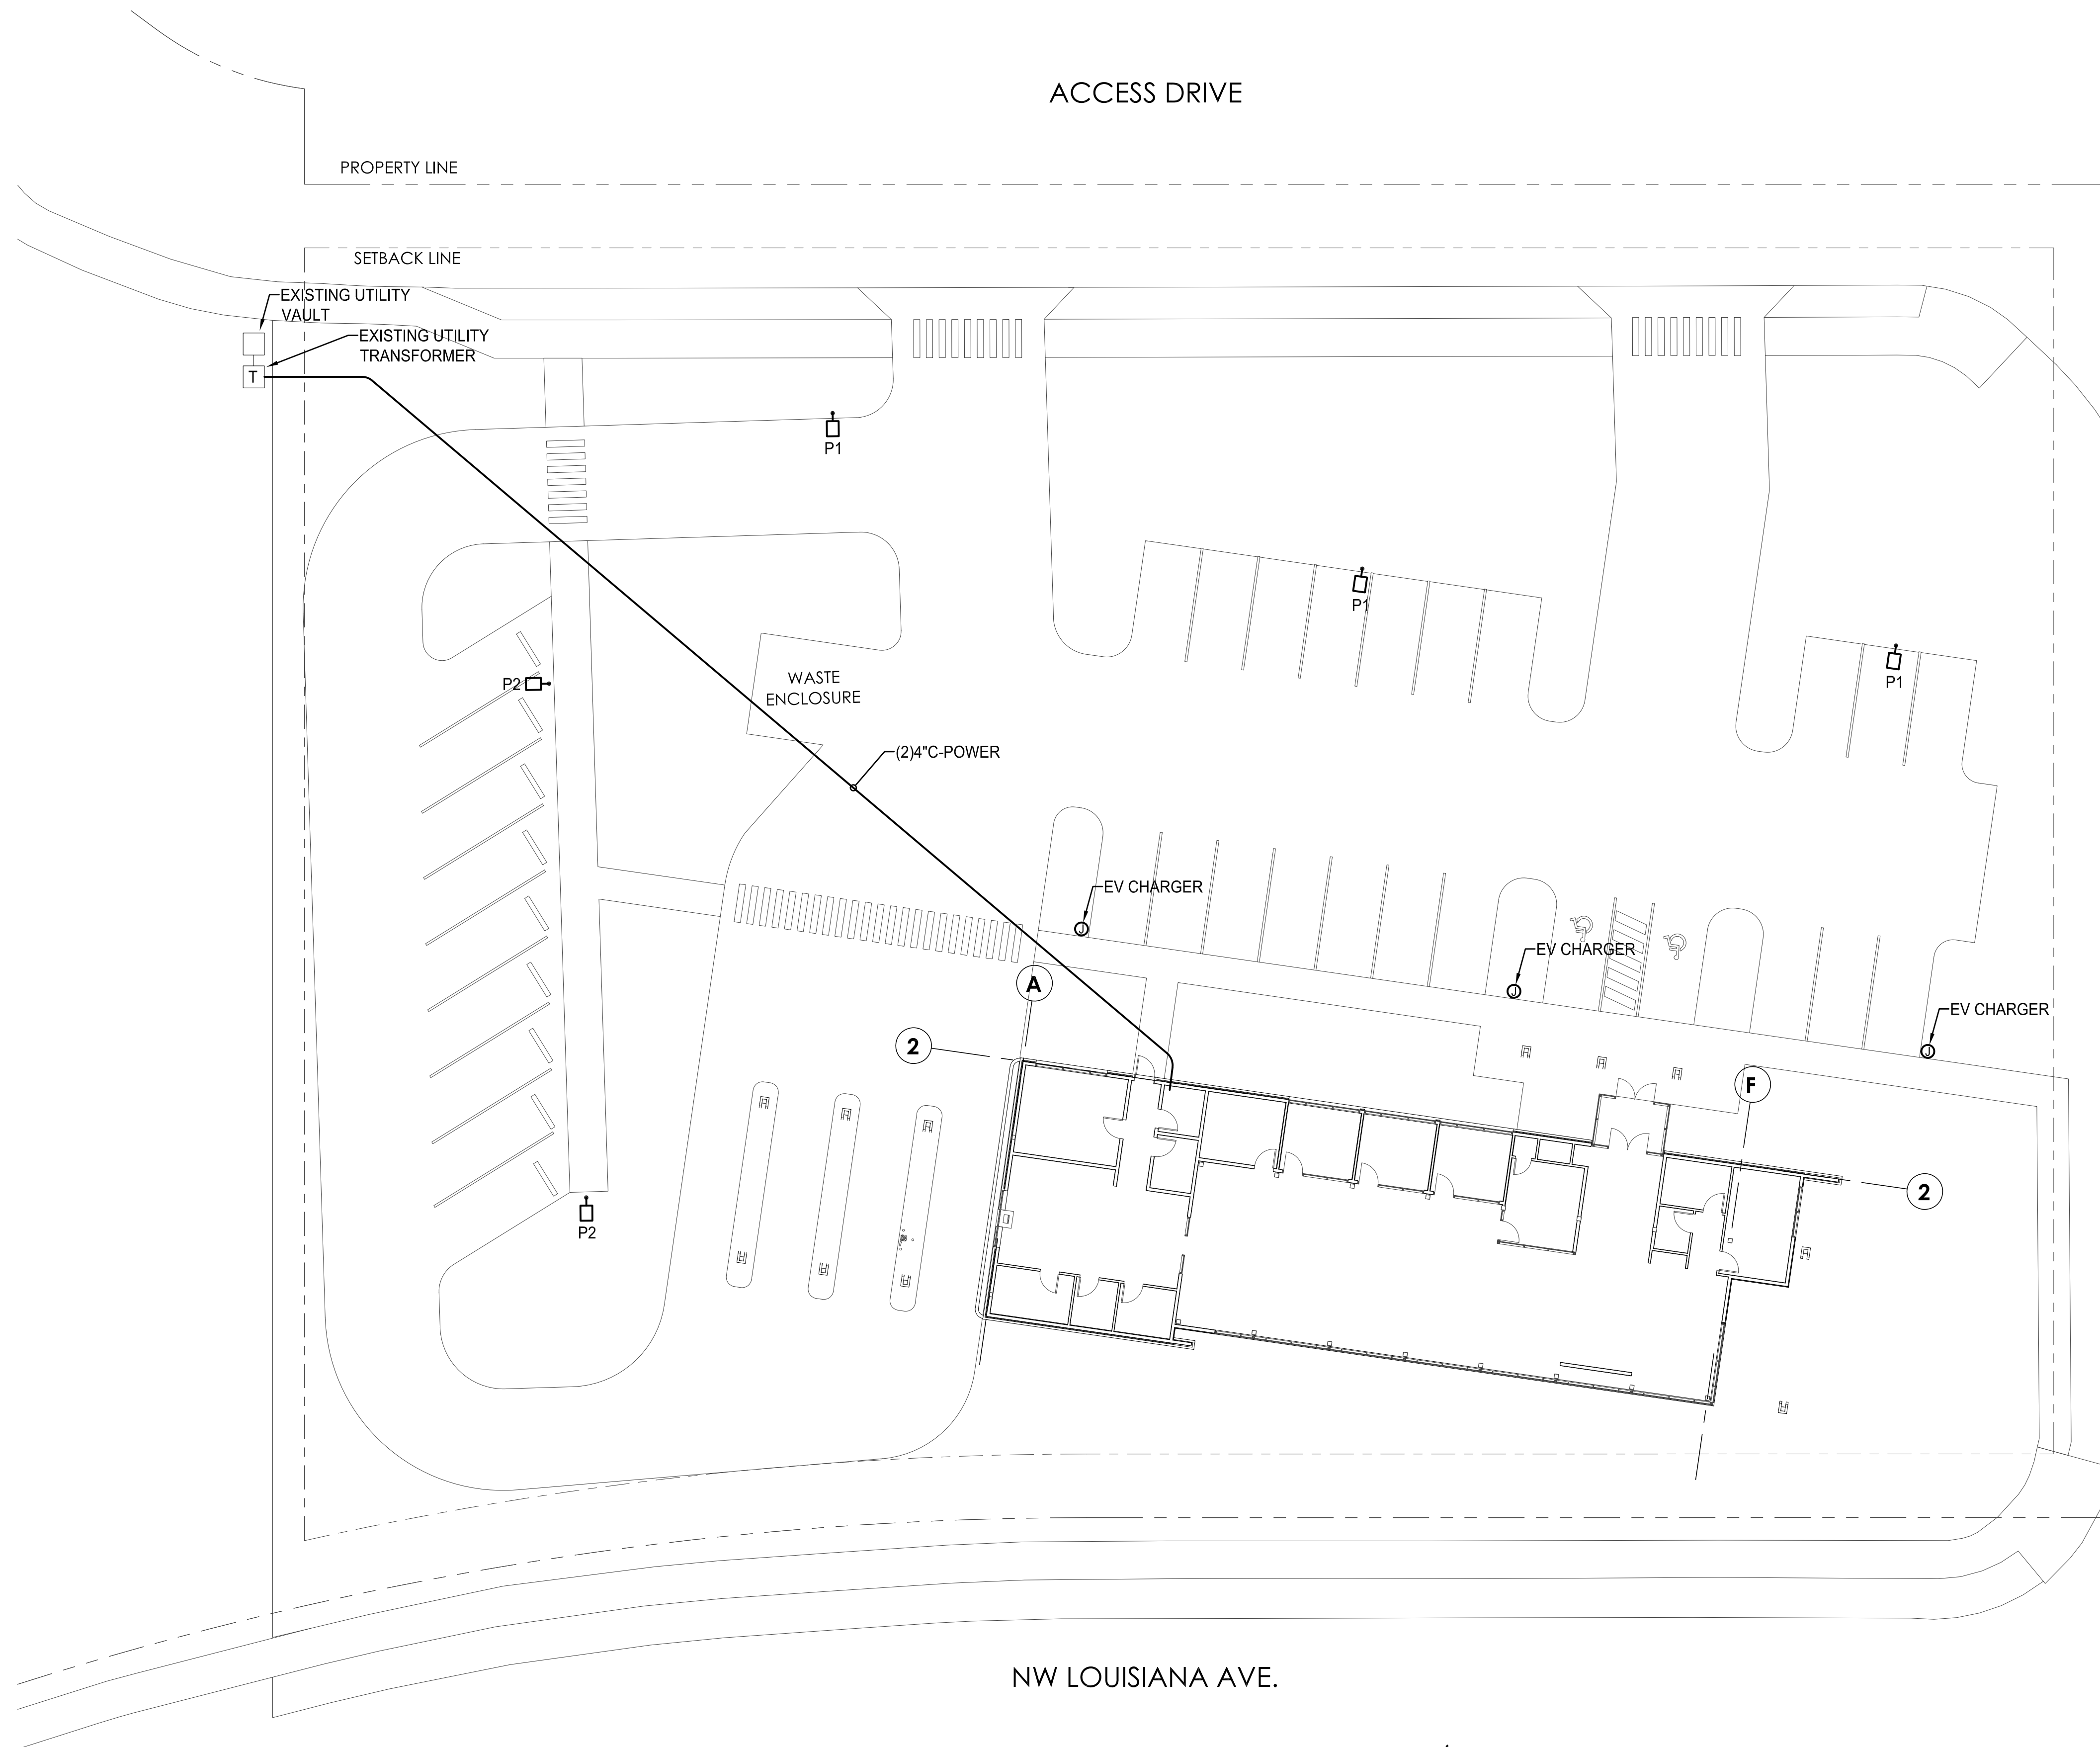

ELECTRICAL SITE PLAN
 SCALE: 1"=15'-0"

